

NOTE:
FOR ACCURATE RIGHT OF WAY DATA, CONTACT
RIGHT OF WAY ENGINEERING AT THE DISTRICT OFFICE.

Dist#	COUNTY	ROUTE	POST MILE TOTAL PROJECT	SHEET NO.	TOTAL SHEETS
03	ED, Plg	89	21.27214 0.0/18.5		

Thomas R. Ruttsch 2-24-11
REGISTERED CIVIL ENGINEER DATE

PLANS APPROVAL DATE

THE STATE OF CALIFORNIA OR ITS OFFICERS OR AGENTS SHALL NOT BE RESPONSIBLE FOR THE ACCURACY OR COMPLETENESS OF SCANNED COPIES OF THIS PLAN SHEET.


L.A.S. RUTTSCH
No. 41791
Exp. 12-31-11
CIVIL
STATE OF CALIFORNIA

STATE OF CALIFORNIA - DEPARTMENT OF TRANSPORTATION
NORTH REGION
DIVISION OF ENGINEERING

FUNCTIONAL SUPERVISOR
K. KEATON

CALCULATED/DESIGNED BY
CHECKED BY
V. LAO
T. RUTTSCH


REVISOR BY
DATE REVISOR
DATE REVISOR

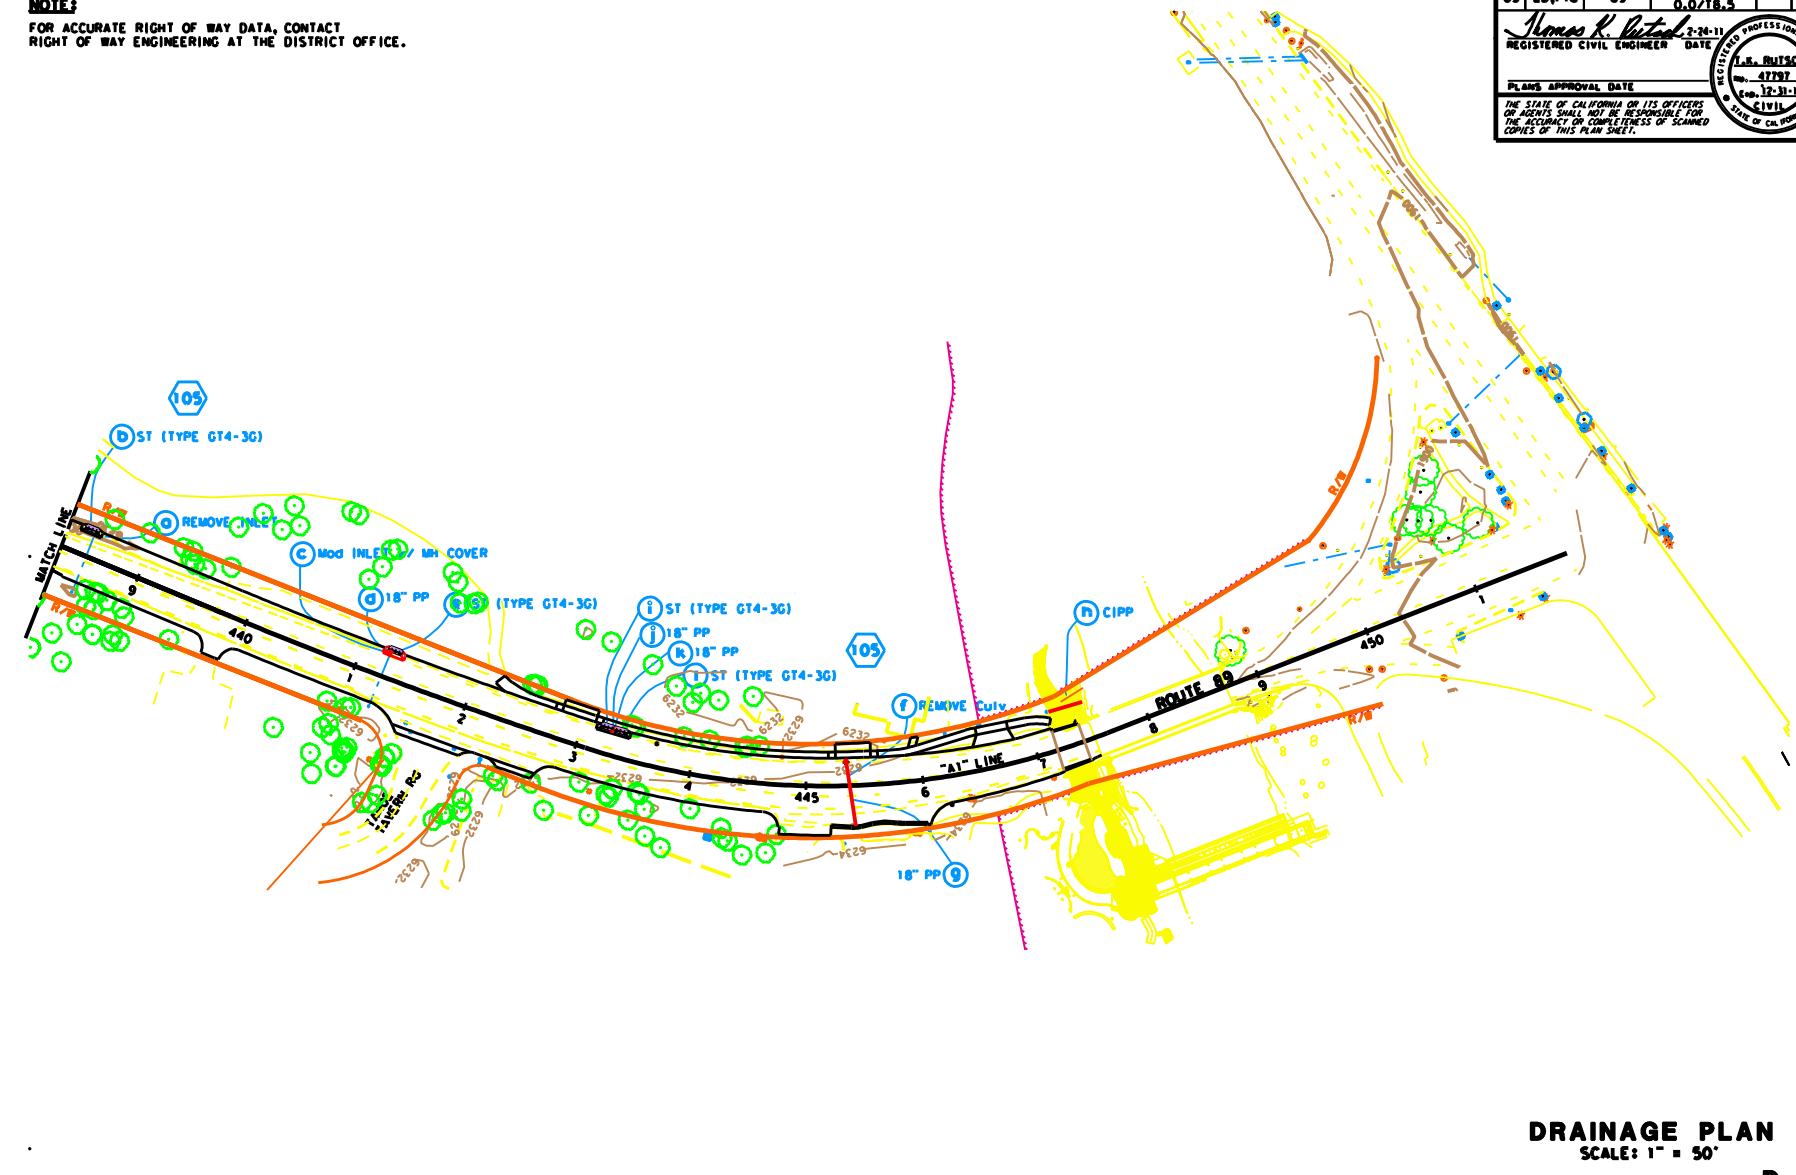

DRAINAGE PLAN
SCALE: 1" = 50'

D-19

 THIS PLAN ACCURATE FOR DRAINAGE WORK ONLY



DATE PLOTTED ==> DATE
TIME PLOTTED ==> TIME